

DISCONNECT SWITCH NOTES

1. FOR LOCATIONS OF COLUMN MOUNTED DISCONNECT SWITCHES REFER TO SCHEDULES ON DRAWING.


MATCH LINE
FOR CONTINUATION SEE DWG. HE-2.072

NOTE: REFER TO ELECTRICAL GENERAL NOTES FOR FURTHER INFO.

REFER TO ELECTRICAL GENERAL NOTES FOR FURTHER INFO.

NOTE: SW SWITCH AT UNIT (TYP.)

NOTE: SW SWITCH AT UNIT (TYP.)

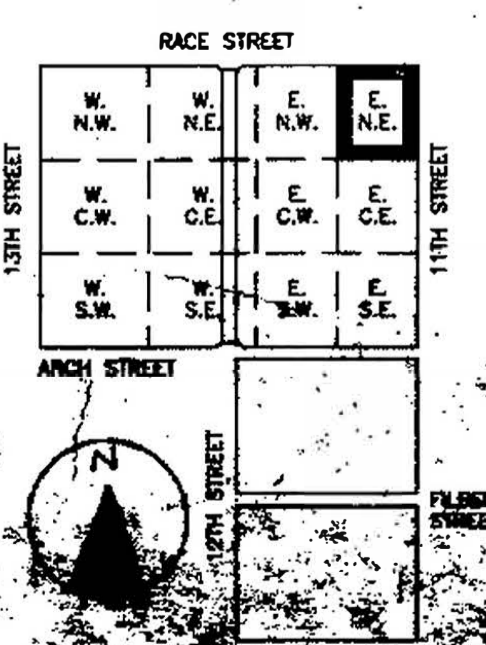

PENNSYLVANIA CONVENTION CENTER PHILADELPHIA, PENNSYLVANIA

VITETTA GROUP
ASSOCIATE ARCHITECTS

KELLY MAHEIG ARCHITECTS & PLANNERS, INC.

LIVINGSTON ROSENWINKEL, P.C.
ARCHITECTS & PLANNERS
CONSULTING ARCHITECTS

PENNELL & WILTBERGER, INC.

PHILADELPHIA DESIGN COLLABORATIVE

CONSULTING ENGINEERS


REVISIONS

1	ADDITIONAL #2
2	10/24/10
3	ADDITIONAL #8 11/21/10

All drawings shall be verified by contractor and architect prior to construction. If any discrepancies are noted, they shall be resolved before proceeding with construction.

David Higgins
DRAWING TITLE
**POWER PLAN
HALL LEVEL
63**

BLOCK

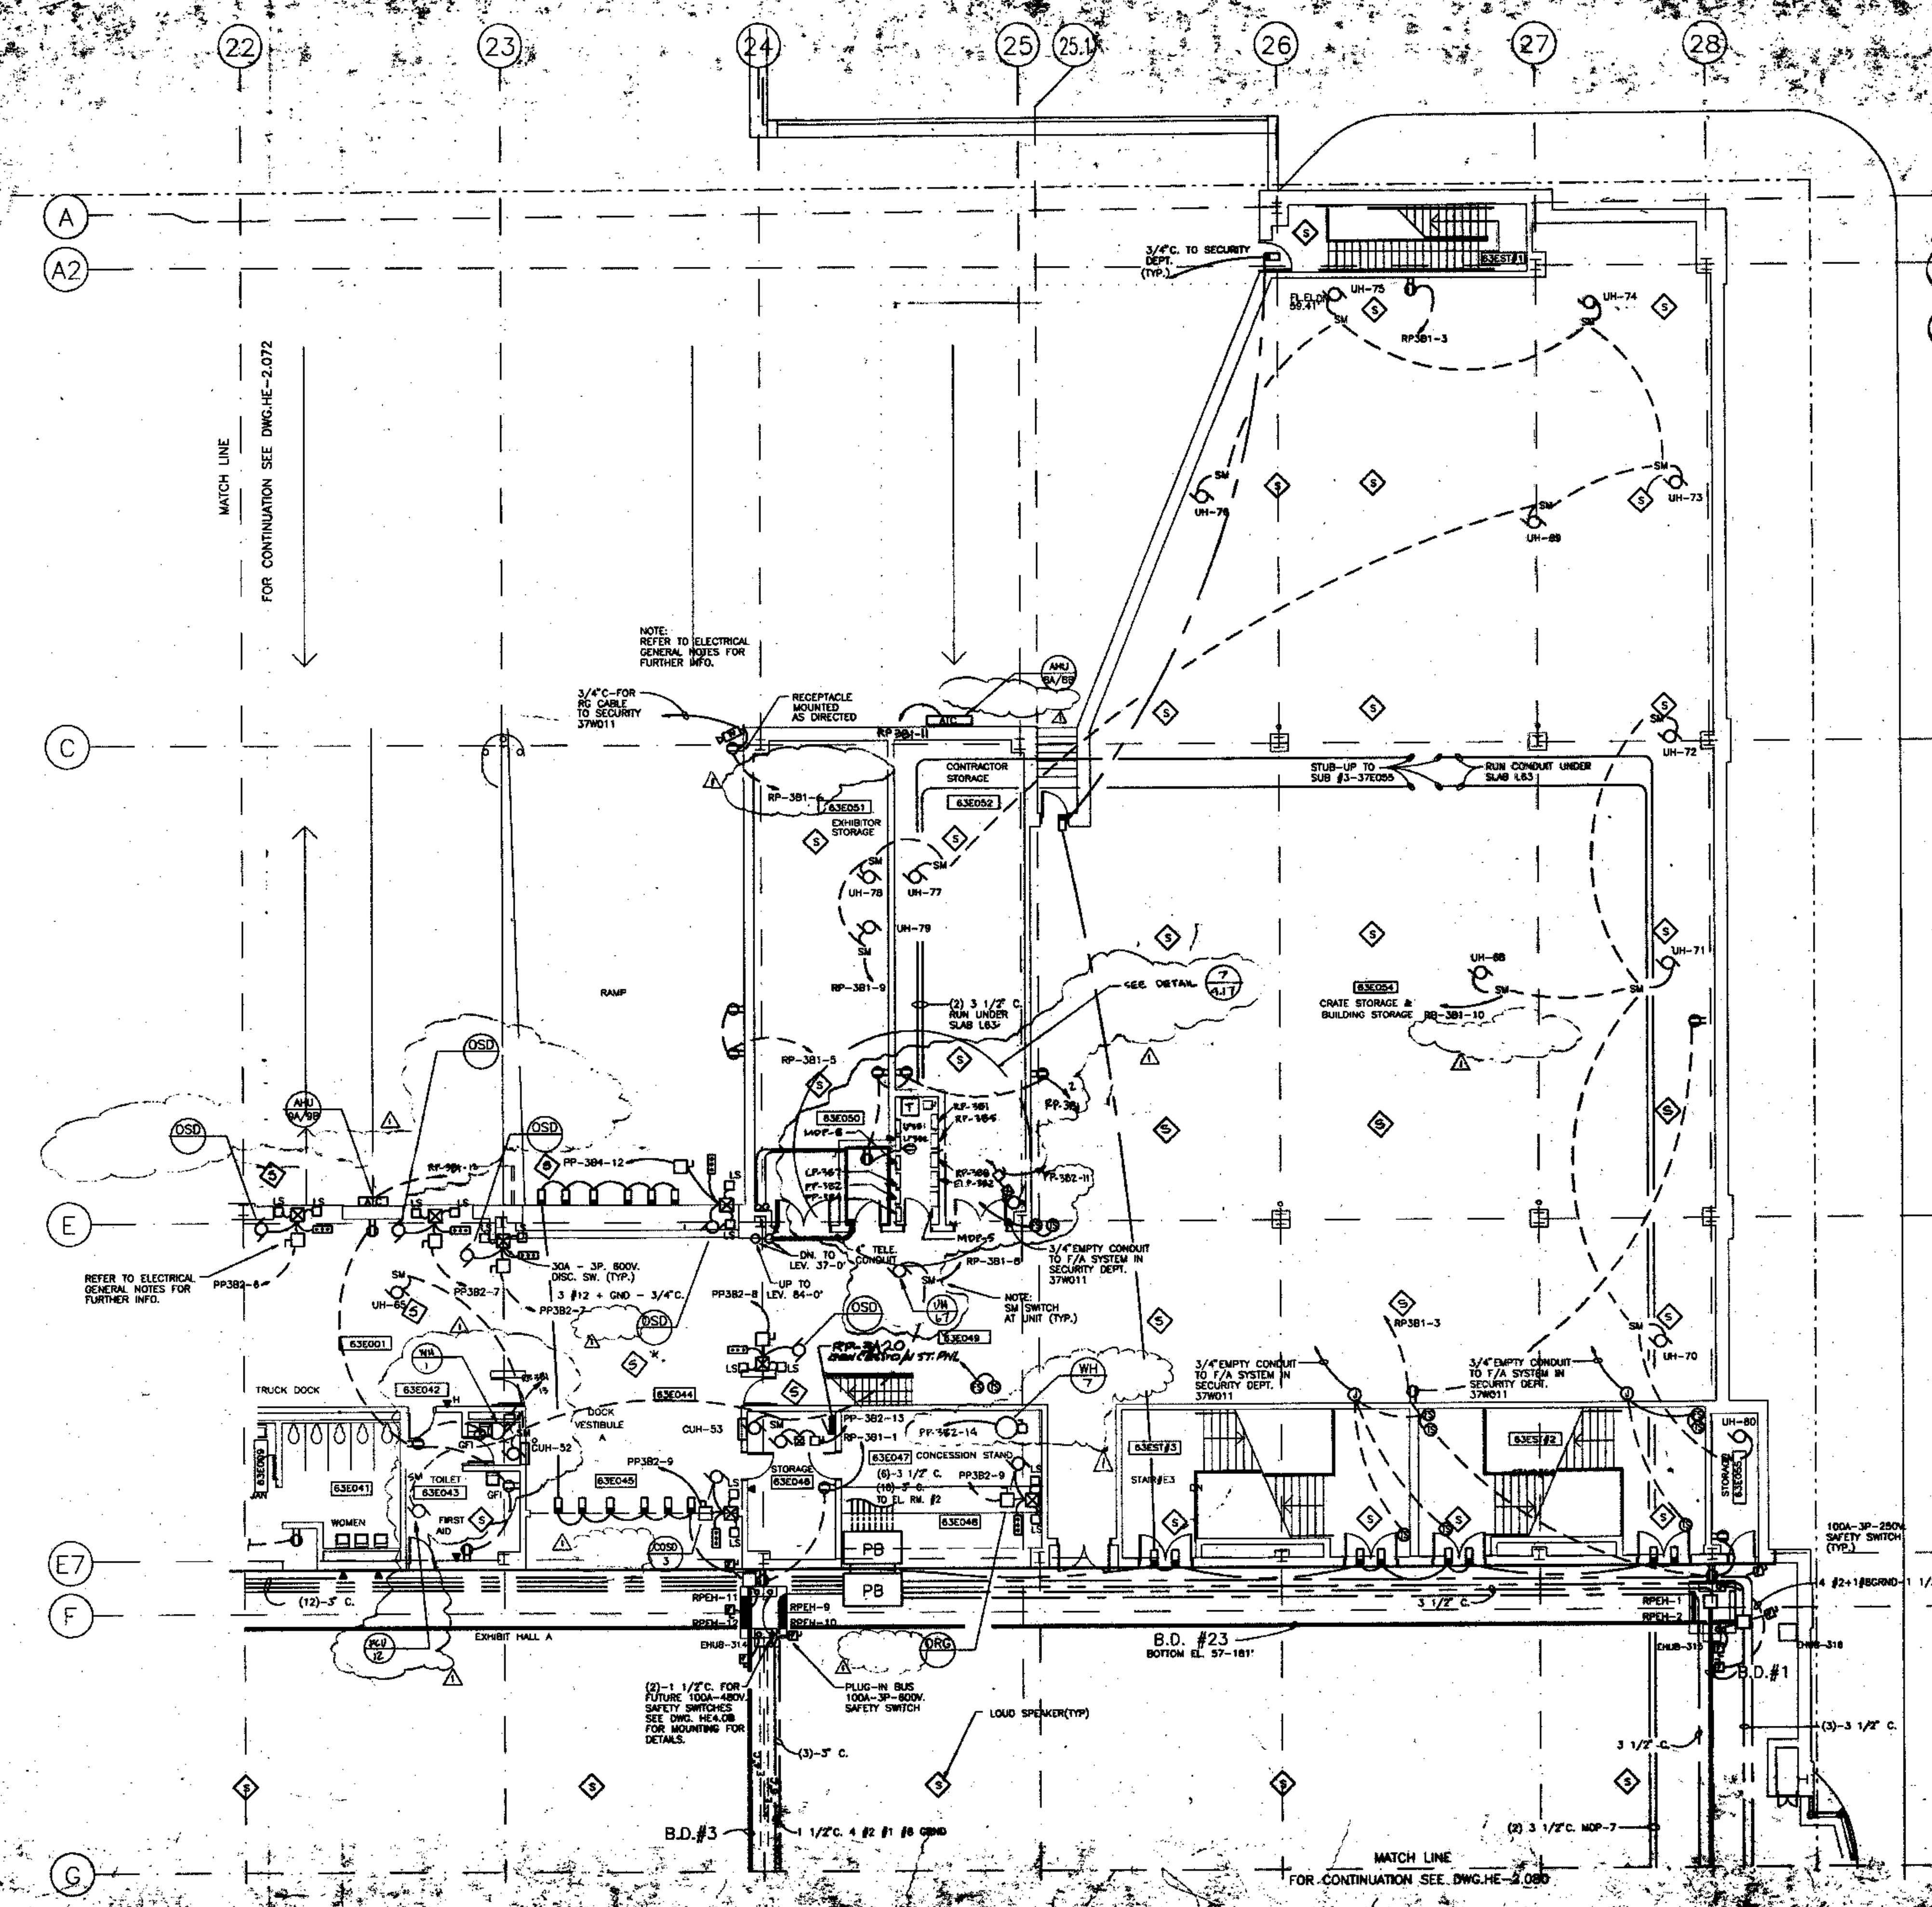

DISCONNECT SWITCHES

1. FOR LOCATIONS OF COLUMN MOUNTED DISCONNECT SWITCHES REFER TO SCHEDULES ON DRAWING.

MATCH LINE
FOR CONTINUATION SEE DWG. HE-2.072

NOTE: REFER TO ELECTRICAL GENERAL NOTES FOR FURTHER INFO.


REFER TO ELECTRICAL GENERAL NOTES FOR FURTHER INFO.

(2)-1 1/2\"/>

PLUG-IN BUS 100A-3P-800V SAFETY SWITCH SEE DWG. HEADS FOR MOUNTING FOR DETAILS.

LOUD SPEAKER(TYP)

MATCH LINE
FOR CONTINUATION SEE DWG. HE-2.080

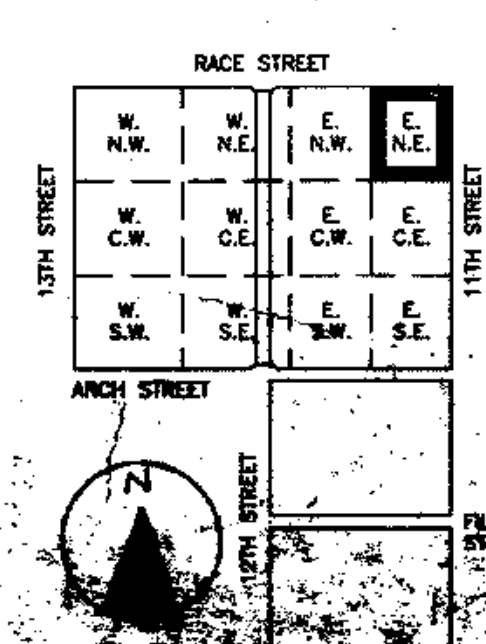

VITETTA GROUP
ASSOCIATES ARCHITECTS

KRUY, MAELIG ARCHITECTS & PLANNERS, INC.

LIVINGSTON ROSENWINKEL, P.C.
ARCHITECTS & PLANNERS
CONSULTING ARCHITECTS

PENNELL & WILTBERGER, INC.

PHILADELPHIA DESIGN COLLABORATIVE

CONSULTING ENGINEERS

REVISIONS


1	ADDITIONAL #2	12/24/12
2	ADDITIONAL #8	11/21/12

All dimensions shall be verified by contractor and architect notified of any discrepancies before proceeding with construction.



POWER PLAN
HALL LEVEL
63

PENNSYLVANIA CONVENTION CENTER PHILADELPHIA, PENNSYLVANIA

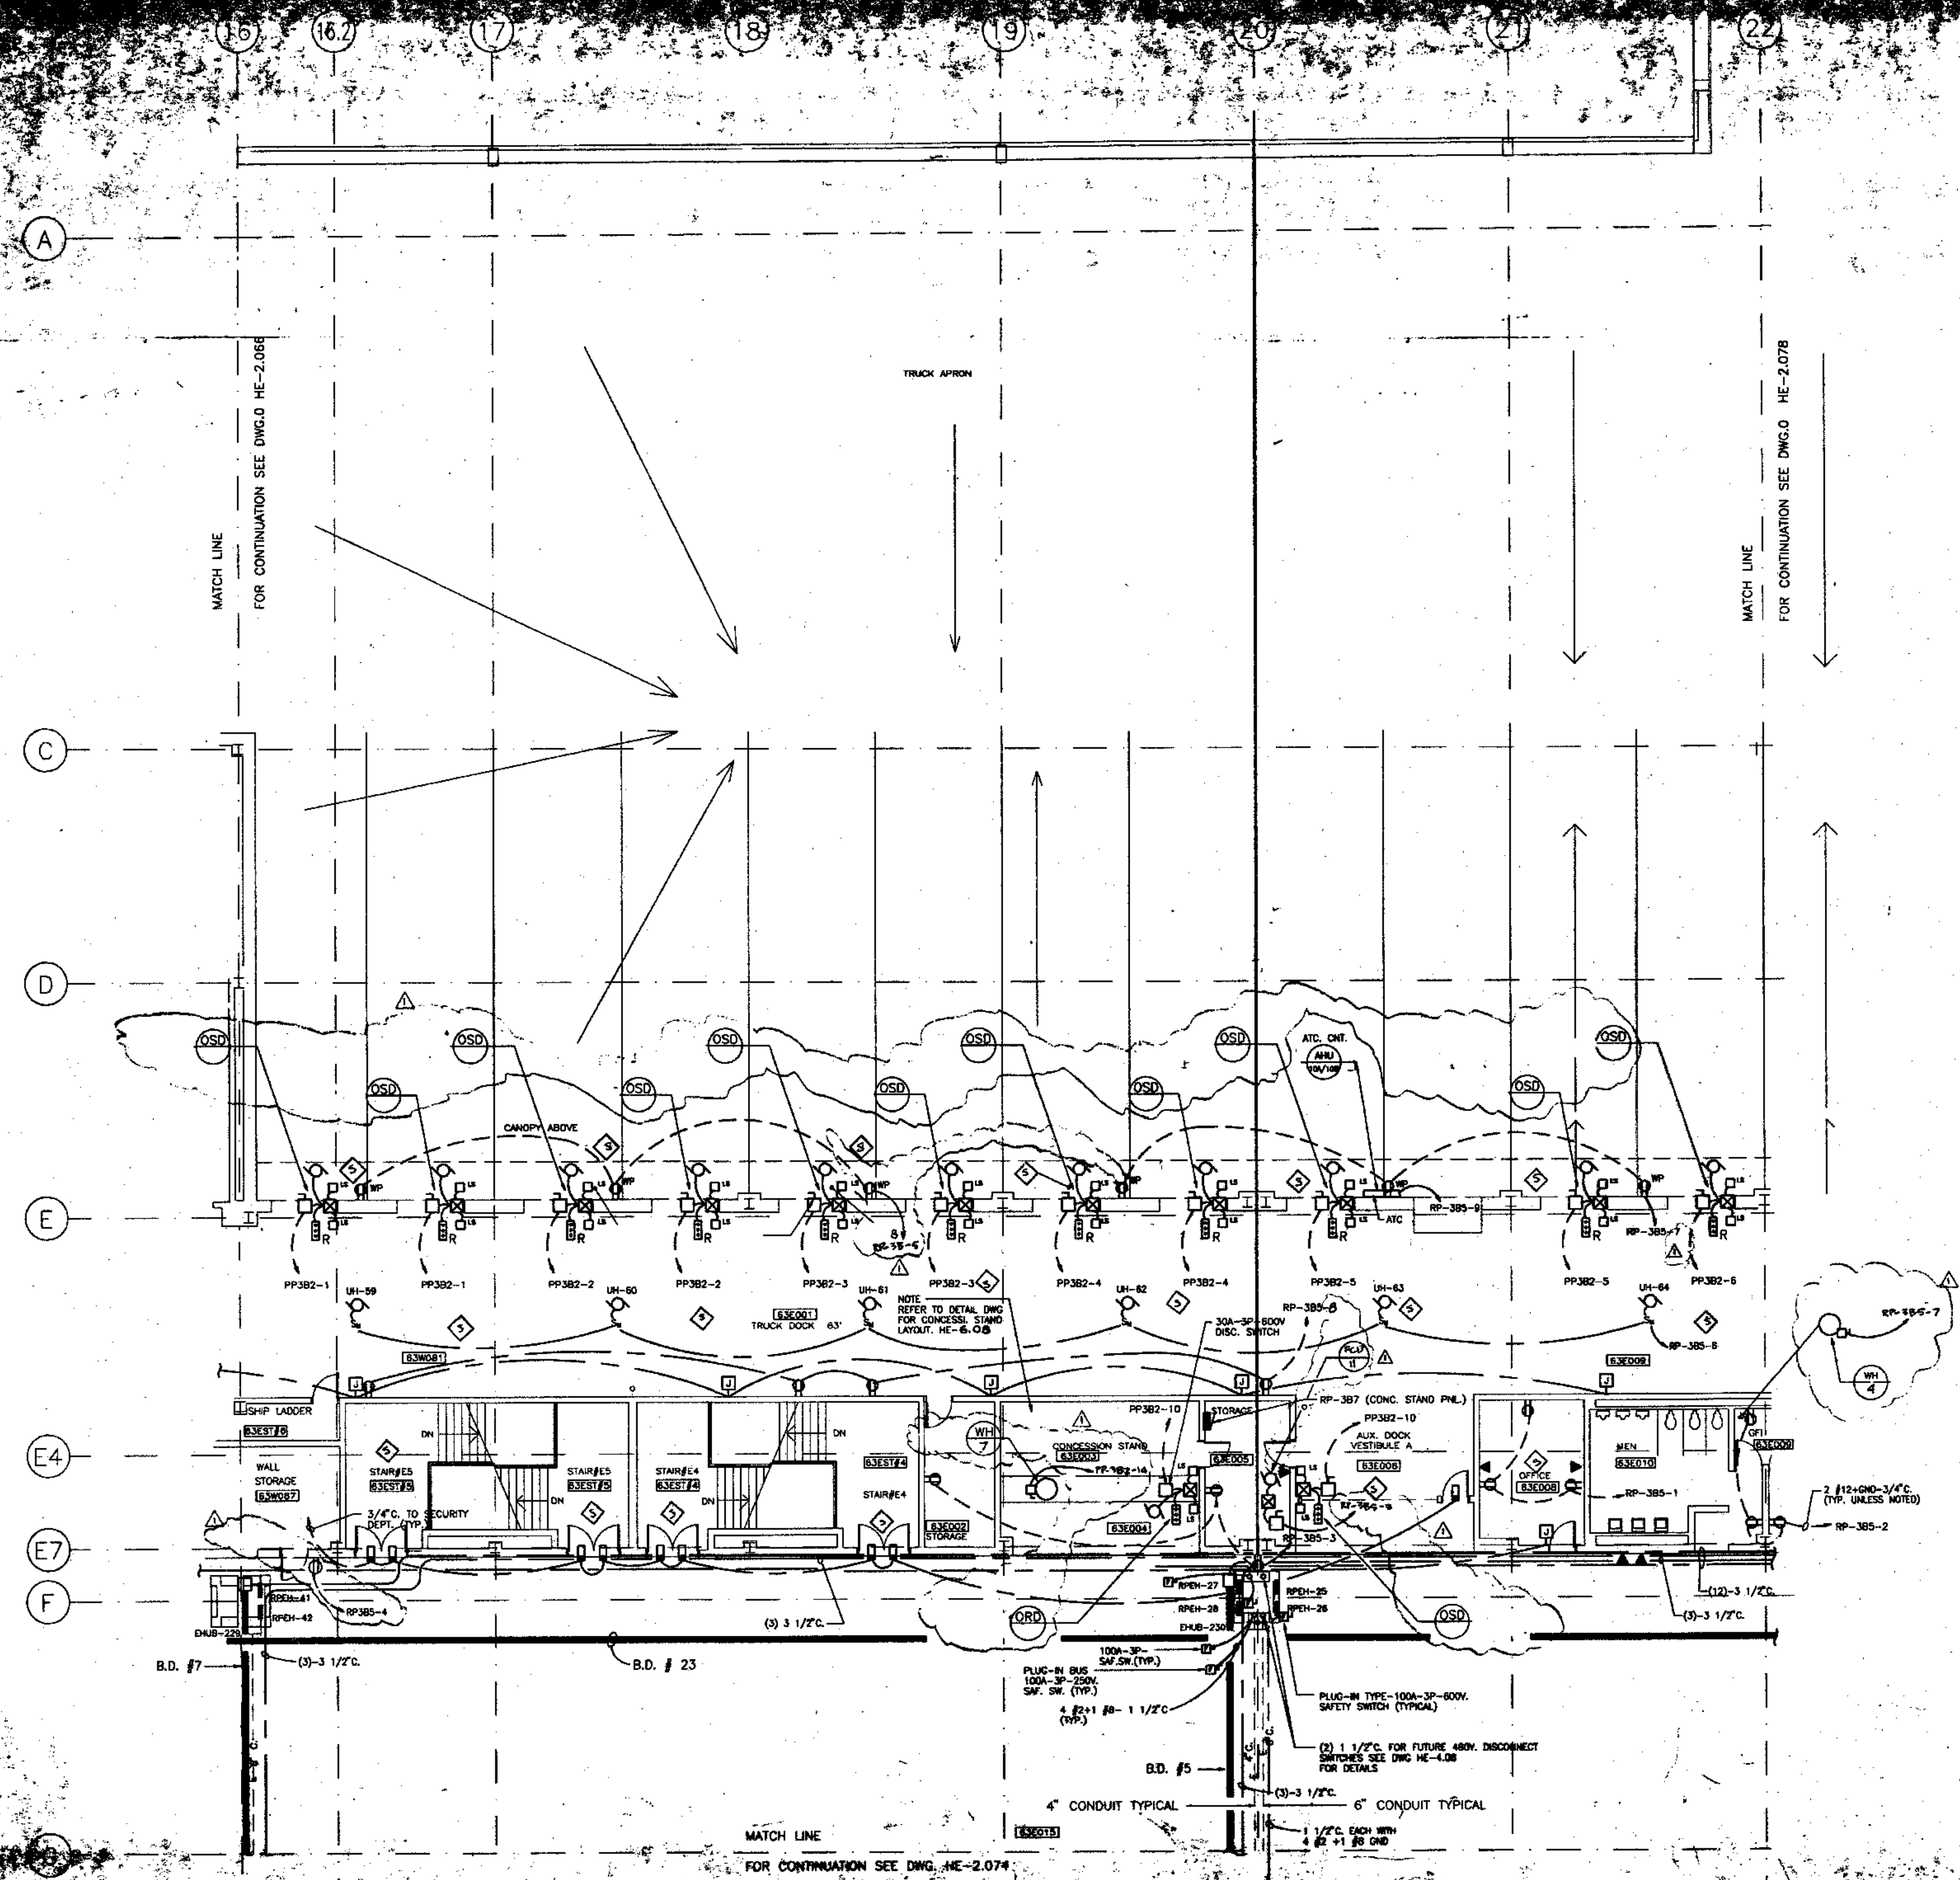

DISCONNECT SWITCH NOTES

1. FOR LOCATIONS OF COLUMN MOUNTED DISCONNECT SWITCHES REFER TO SCHEDULE ON THIS SHEET.

NOTE - REFER TO DETAIL DWG FOR CONCESSION STAND LAYOUT, HE-6.08

RACE STREET			
W. N.W.	W. N.E.	E. N.W.	E. N.E.
W. C.W.	W. C.E.	E. C.W.	E. C.E.
ARCH STREET			
W. S.W.	W. S.E.	E. S.W.	E. S.E.



VTETTA GROUP
ASSOCIATED ARCHITECTS

KEEY / MARBO ARCHITECTS & PLANNERS, INC

LIVINGSTON/ROSENWINKEL P.C. ARCHITECTS & PLANNERS
CONSULTING ARCHITECTS

PENNEL & WILTBERGER INC.

PHILADELPHIA DESIGN COLLABORATIVE

CONSULTING ENGINEERS

REVISIONS


APPENDIX 4 #2
10/24/16

APPENDIX 4 #3 11/11/16

PHILADELPHIA CONVENTION CENTER
PENNSYLVANIA

All dimensions shall be verified by contractor and architect notified of any discrepancies before proceeding with construction.

POWER PLAN
HALL LEVEL
63

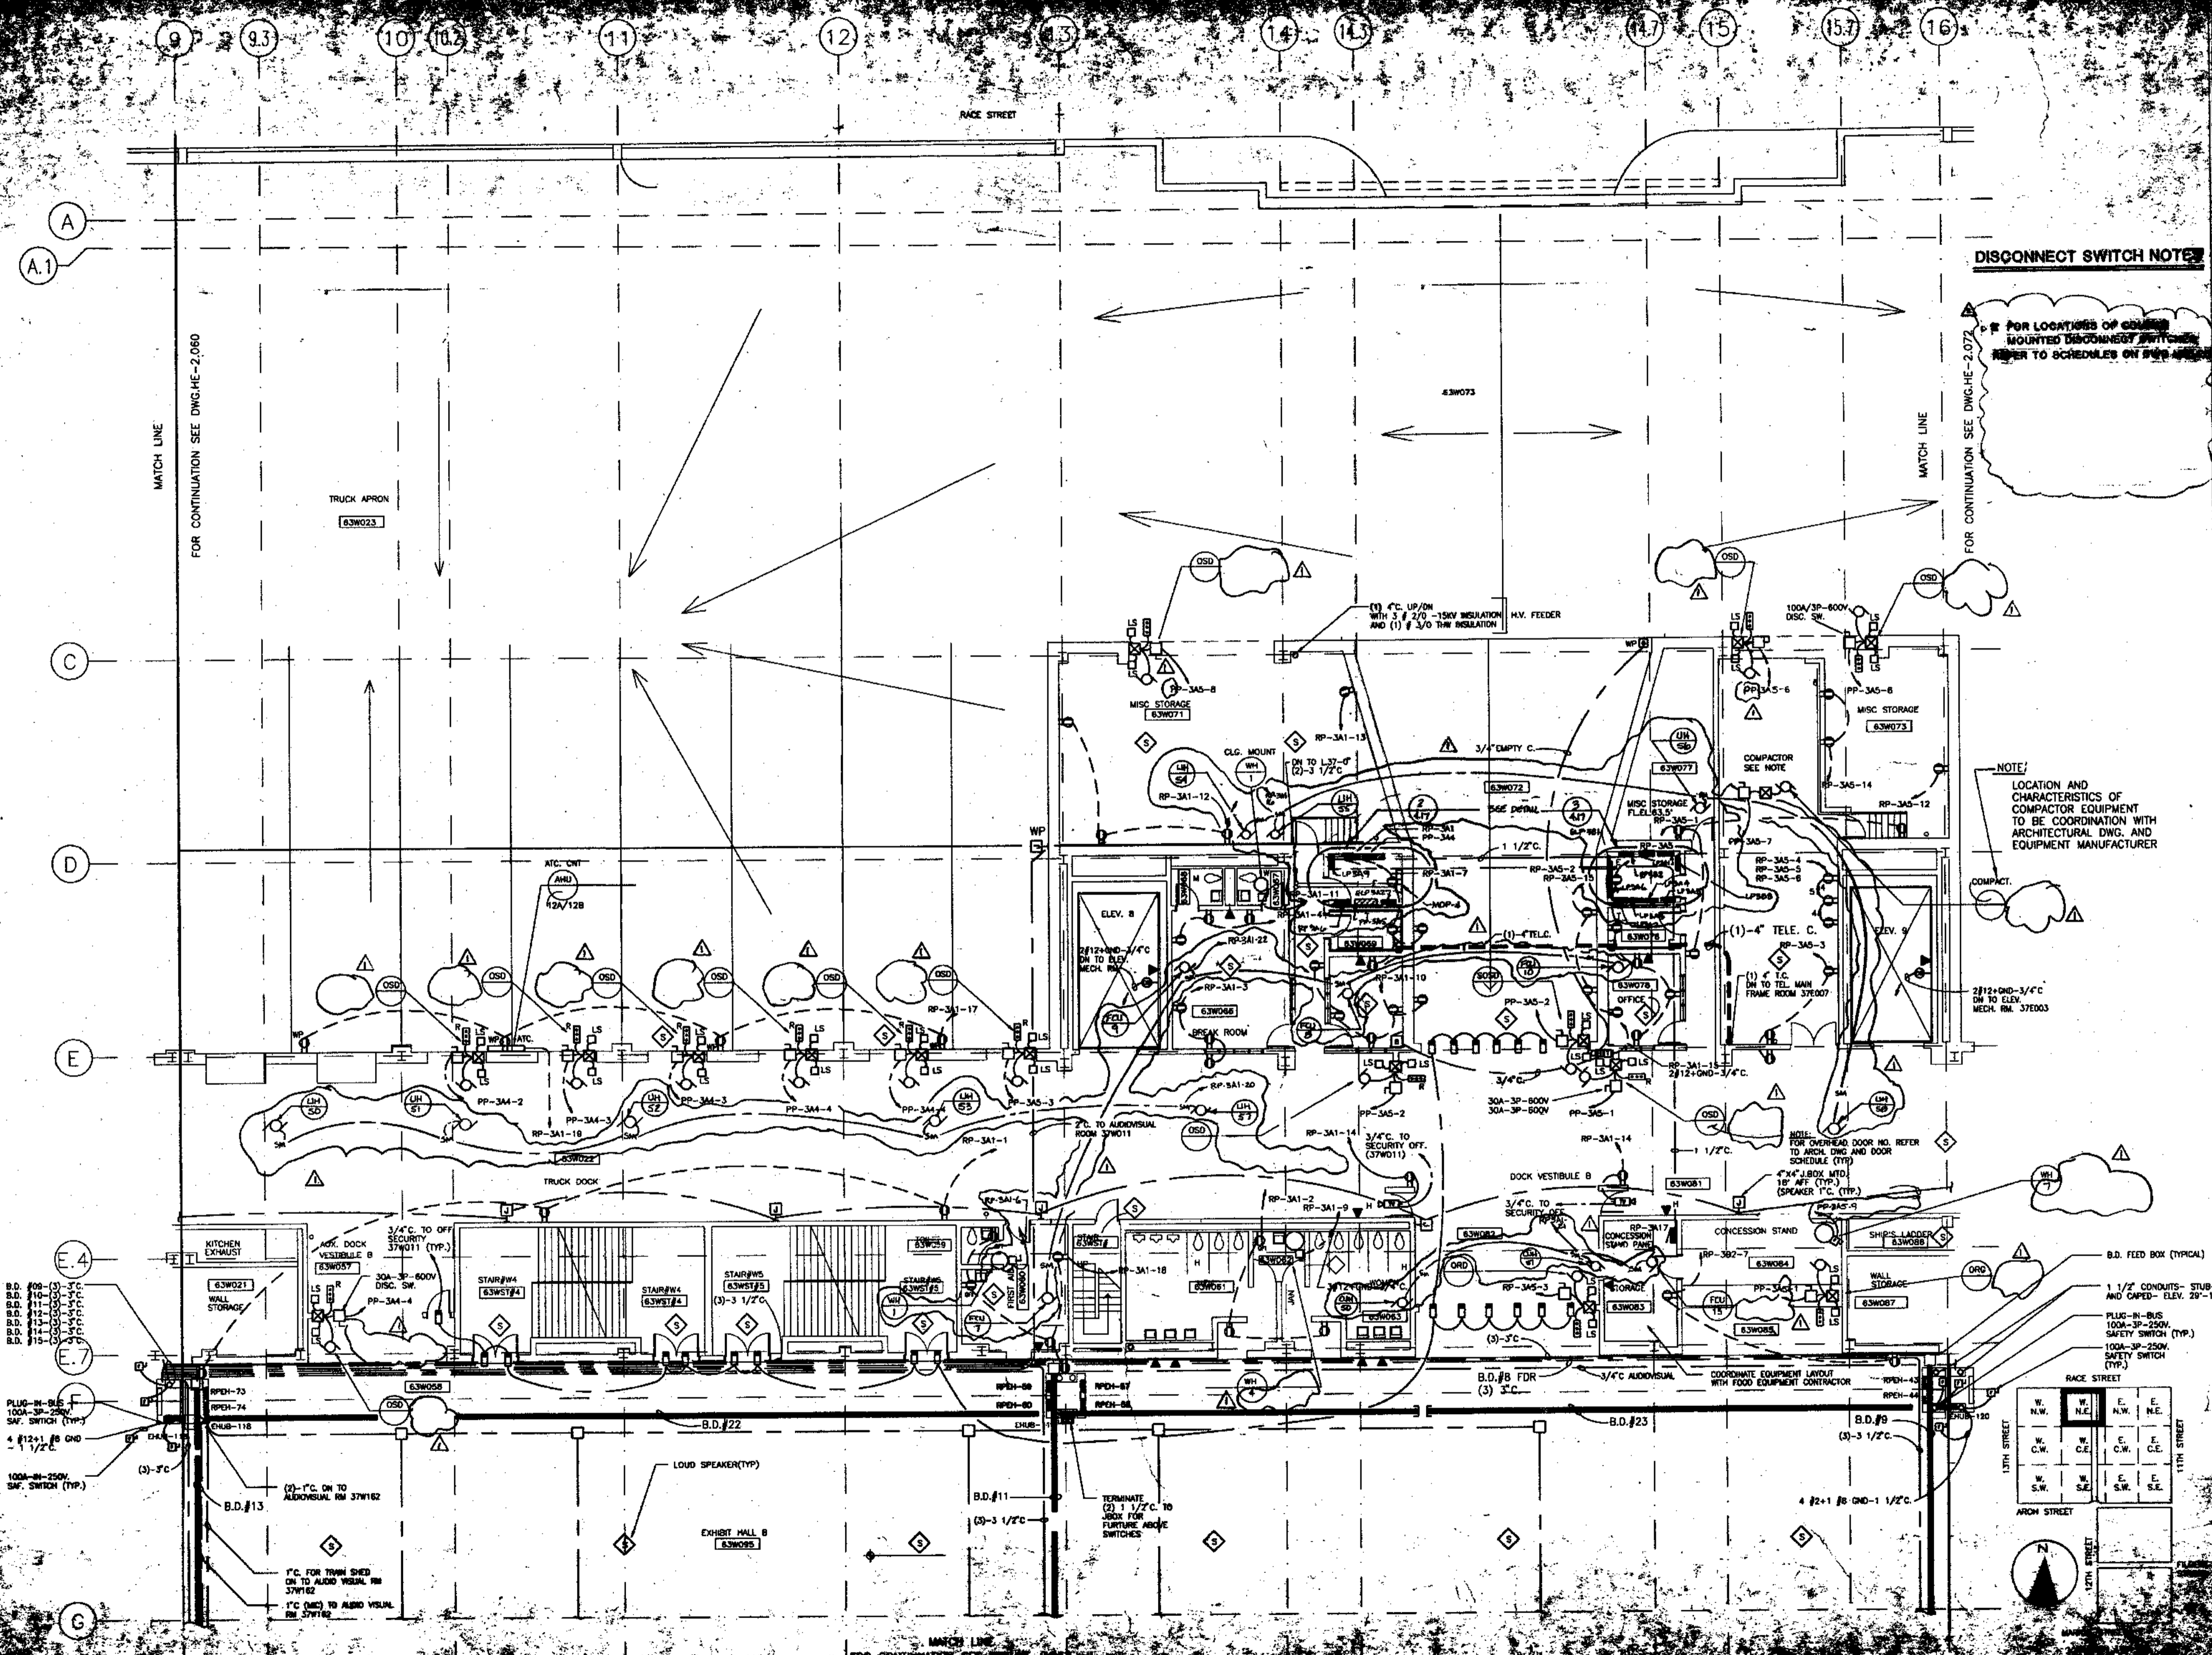

DISCONNECT SWITCH NOTES

FOR LOCATIONS OF COMPACTOR MOUNTED DISCONNECT SWITCHES REFER TO SCHEDULES ON PAGES 10-11

NOTE: LOCATION AND CHARACTERISTICS OF COMPACTOR EQUIPMENT TO BE COORDINATION WITH ARCHITECTURAL DWG. AND EQUIPMENT MANUFACTURER.

PHILADELPHIA CONVENTION CENTER
 VITETTA GROUP
 ASSOCIATED ARCHITECTS
 KELLY MAILED ARCHITECTS & PLANNERS, INC.
 LIVINGSTON ROSENWINKEL P.C. ARCHITECTS & PLANNERS
 CONSULTING ARCHITECTS
 PENNELL & WILTBERGER INC.
 PHILADELPHIA DESIGN COLLABORATIVE
 CONSULTING ENGINEERS


REVISIONS


NO.	DATE	DESCRIPTION
1	10/21/90	ADJUSTMENT TO 10/21/90
2	11/14/90	ADJUSTMENT TO 11/14/90

All dimensions shall be verified by contractor and architect notified of any discrepancies before proceeding with construction.



POWER PLAN
 FLOOR LEVEL

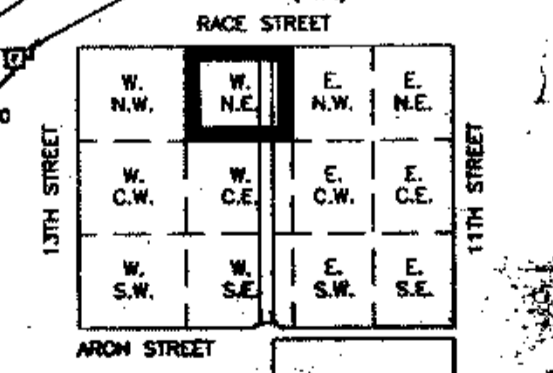

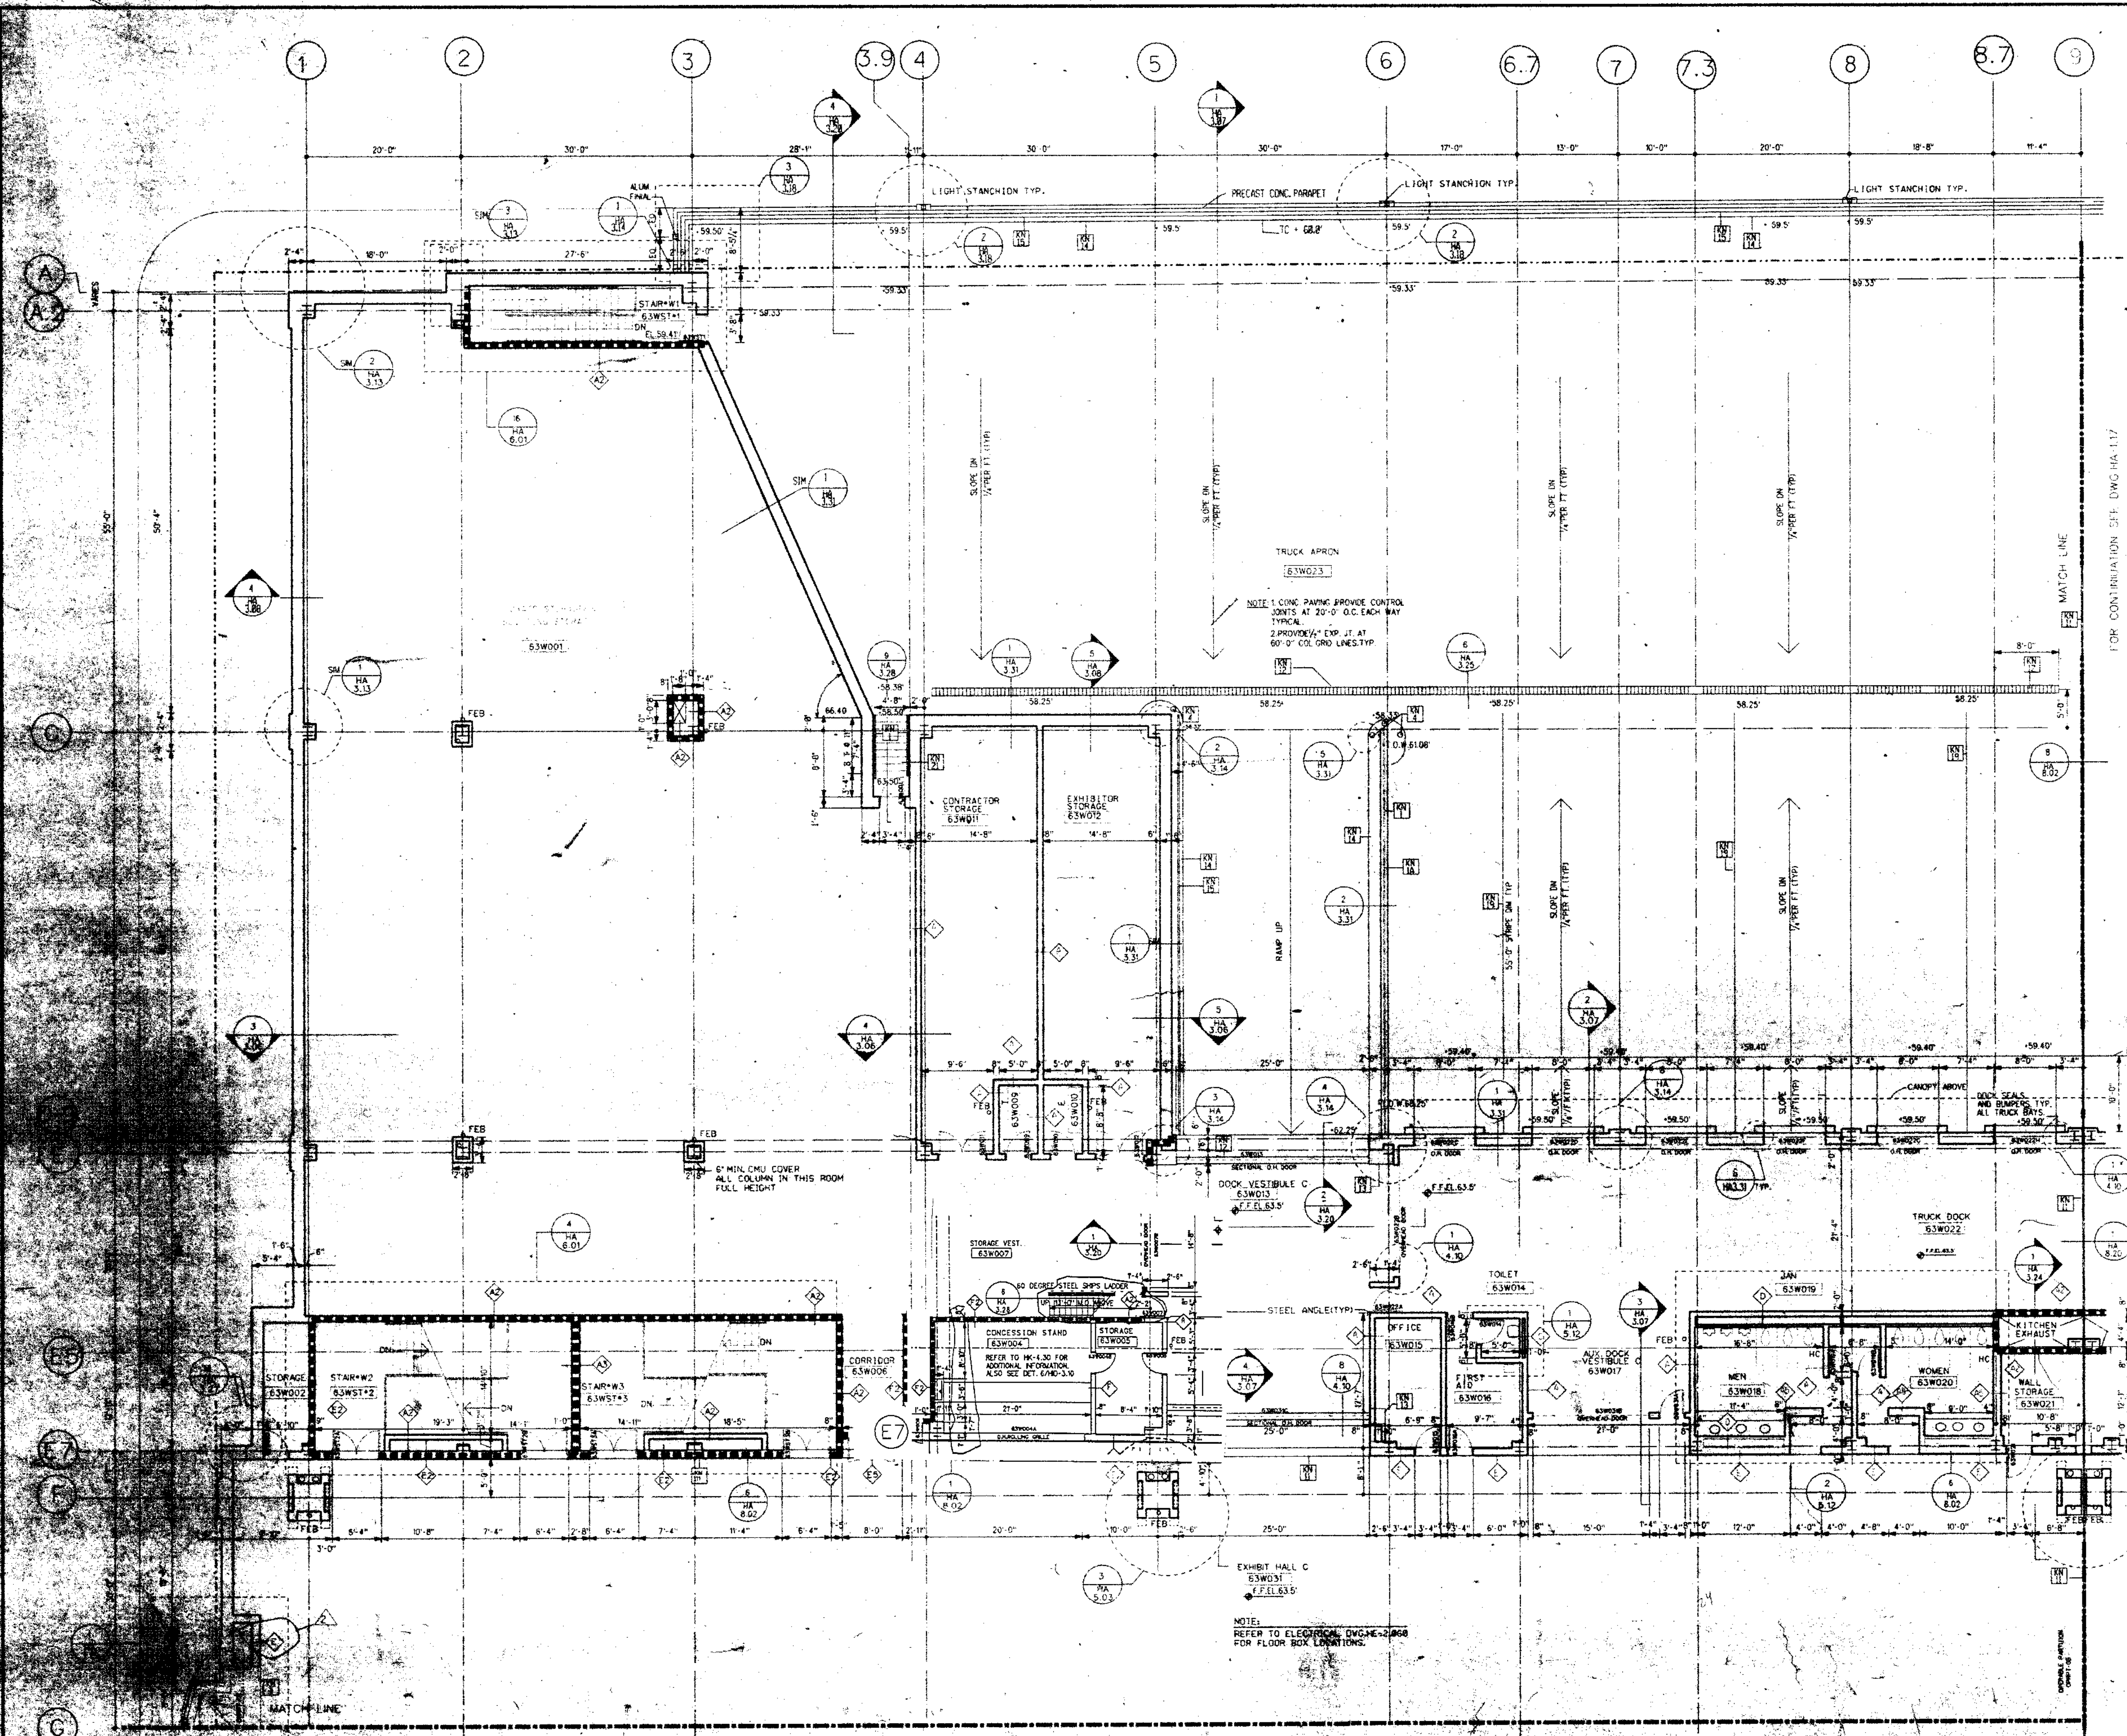

GENERAL FLOOR PLAN NOTES:


1. ALL DIMENSIONS GIVEN ARE NOMINAL AND ARE TAKEN TO THE FACE OF CMU CONSTRUCTION WHERE PARTITIONS ARE CMU OR BACKED UP BY CMU. DIMENSIONS AT METAL FRAME G.W.B. PARTITIONS ARE GIVEN TO FINISH FACE.
2. FOR PARTITION TYPES REFER TO DWG HA-8.01. WHERE A PARTITION TYPE IS NOT INDICATED ON THESE DRAWINGS THE PARTITION TYPE IS THE SAME AS INDICATED BY THE MARKED SHIRAZ CONSTRUCTION.
3. WALLS INDICATED TO BE RATED CONSTRUCTION SHALL BE CONTINUOUS TO EXTERIOR WALL AND UNDERSIDE OF DECK OR SLAB.
4. FOR ADDITIONAL INFO REGARDING FOOD SERVICE AREAS REFER TO FOOD SERVICE DWG SERIES "FM".
5. FOR MILLWORK & CASEWORK REFER TO INTERIOR DESIGN DRAWINGS, SERIES "ID".
6. FOR FLOORING PATTERNS & MATERIALS REFER TO INTERIOR DESIGN DRAWINGS, SERIES "ID". (NOTE: EXTENT OF STONE FLOORING REQUIRING DEPRESSED CONCRETE SLAB IS INDICATED ON HD DRAWINGS ONLY.)
7. FOR EXTENT AND TYPE OF APPLIED FINISHES REFER TO ROOM FINISH SCHEDULE IN SPEC SECTION 09001.
8. FOR EXTENT OF SIDEWALKS, CURBS & MISC. SITE WORK SEE CIVIL ENGINEERING DWGS ("HX-" SERIES & ARCHITECTURAL DWGS ("HA-8-" SERIES)).
9. ALL WOOD WINDOWS & MILLWORK ARE INDICATED ON INTERIOR DESIGN DWGS. (HD DWGS).
10. EXPANSION JOINT COVERS ARE REQUIRED AT ALL INTERIOR WALL & FLOOR CONDITIONS WHERE EXPANSION JOINTS OCCUR THROUGH THE STRUCTURE WHEN NOT INDICATED ON THE PLANS OR SHOWN IN CONDITIONS WHERE SIMILAR CONDITION DOES NOT OCCUR, JOINT COVERS SHALL BE AS INDICATED ON SCHEDULE ON DWG HA-8.02.

KEY NOTES:

- 1. REMOVABLE HANDRAIL
- 2. HANDRAIL
- 3. ORNAMENTAL HANDRAIL (REFER TO DWG HA-5.05)
- 4. SOFFIT ABOVE
- 5. STL BOLLARD
- 6. EDGE OF SLAB
- 7. 1" DEPRESSED SLAB FOR FEED MAT.
- 8. 2" DEPRESSED SLAB FOR VEST. MAT.
- 9. 2" DEPRESSED SLAB FOR WALK IN REF./PREZ.
- 10. 8" DEPRESSED SLAB FOR WALK IN REF./PREZ.
- 11. OPERABLE PARTITION FOR CEILING TRACK & EXTENT OF CMU PARTITION ABOVE CEILING SEE REFLECTED CEILING PLAN.
- 12. 2" EXPANSION JOINT (TYPICAL)
- 13. TRENCH DRAIN
- 14. COUNTER WT. TOWER FOR SECTIONAL DOOR
- 15. 6" CONC. CURB
- 16. GUARD RAIL
- 17. CONCRETE WALK
- 18. CAST IN PLACE CONCRETE STEPS WITH PAINTED STL HANDRAIL
- 19. CONTROL JOINT (TYPICAL)
- 20. PAINTED STRIPES @ EACH TRUCK DOCK
- 21. PROTECTIVE BOLLARDS AT OPERABLE PARTITIONS
- 22. CONC. FILLED METAL PAN STAIRS WITH PTD. METAL HANDRAIL

LEGEND

- MATCH LINE
- COLUMN CENTER LINE
- PROPERTY LINE
- 1/2" FIRE RATED WALL
- 3/4" FIRE RATED WALL
- PARTITION TYPE
- KEY NOTES
- 379048 DOOR NUMBER
- 379049 ROOM NUMBER
- PLAN DETAIL
- SECTION DETAIL
- DIMENSION CENTER LINE OF COLUMN TO FACE CMU
- 1" H.M. BORROWED LIGHTS
- 1" WOOD BORROWED LIGHTS
- SEE HD DWGS.
- T.C. TOP OF CURB

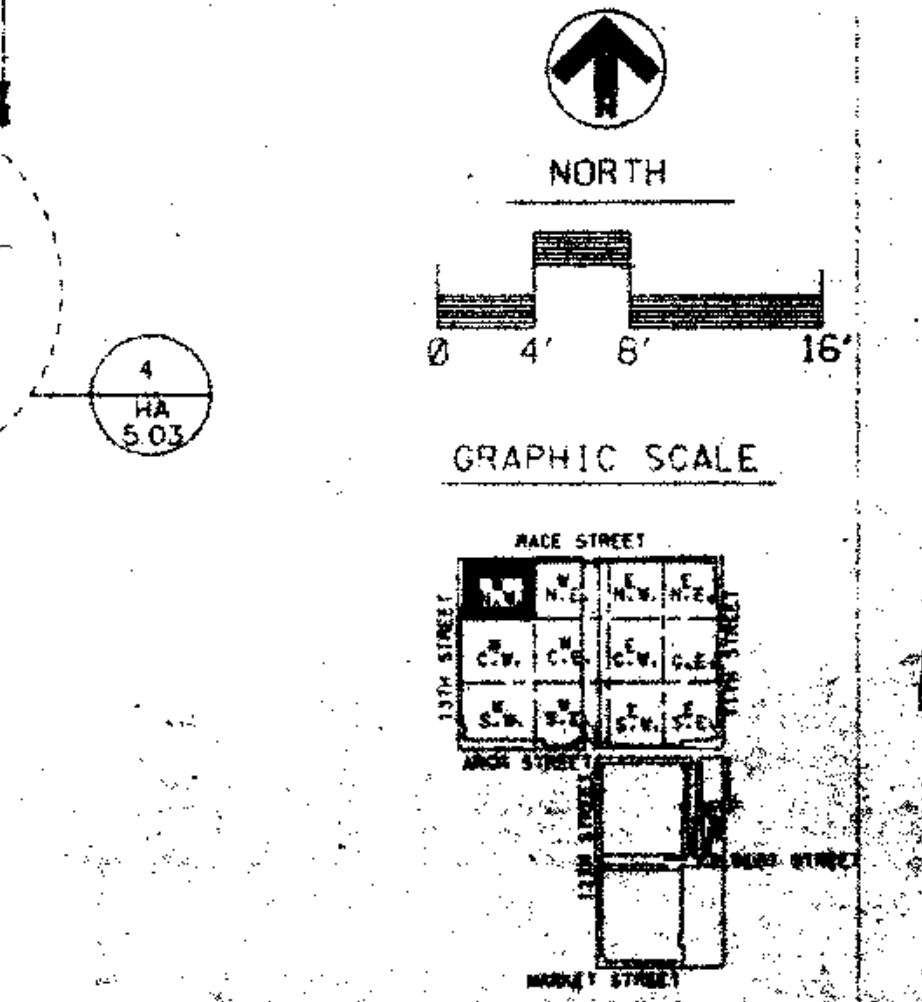

THOMPSON
VENTULETTI
STAINBACK
&
ASSOCIATES, INC.
ARCHITECTS

VITETTA
GROUP
ASSOCIATED ARCHITECT

KELLY/
MAIELLO
ARCHITECTS &
PLANNERS, INC.

LIVINGSTON/
ROSENWINKEL,
P.C.
ARCHITECTS &
PLANNERS
CONSULTING ARCHITECT

REVISIONS

NO.	DESCRIPTION	DATE
1	ADD NO. 3	10-28-88
2	ADD NO. 4	10-28-88


LEGEND

- MATCH LINE
- COLUMN CENTER LINE
- PROPERTY LINE
- 1/2" FIRE RATED WALL
- 3/4" FIRE RATED WALL
- PARTITION TYPE
- KEY NOTES
- 379048 DOOR NUMBER
- 379049 ROOM NUMBER
- PLAN DETAIL
- SECTION DETAIL
- DIMENSION CENTER LINE OF COLUMN TO FACE CMU
- 1" H.M. BORROWED LIGHTS
- 1" WOOD BORROWED LIGHTS
- SEE HD DWGS.
- T.C. TOP OF CURB

All dimensions shall be verified by contractor and architect notified of any discrepancies before proceeding with construction.

RECEIVED
FEB 8 1991
HARDY/KATING/KEMMERS

DRAWING TITLE
FLOOR PLAN
HALL LEVEL
63
RECORD SET

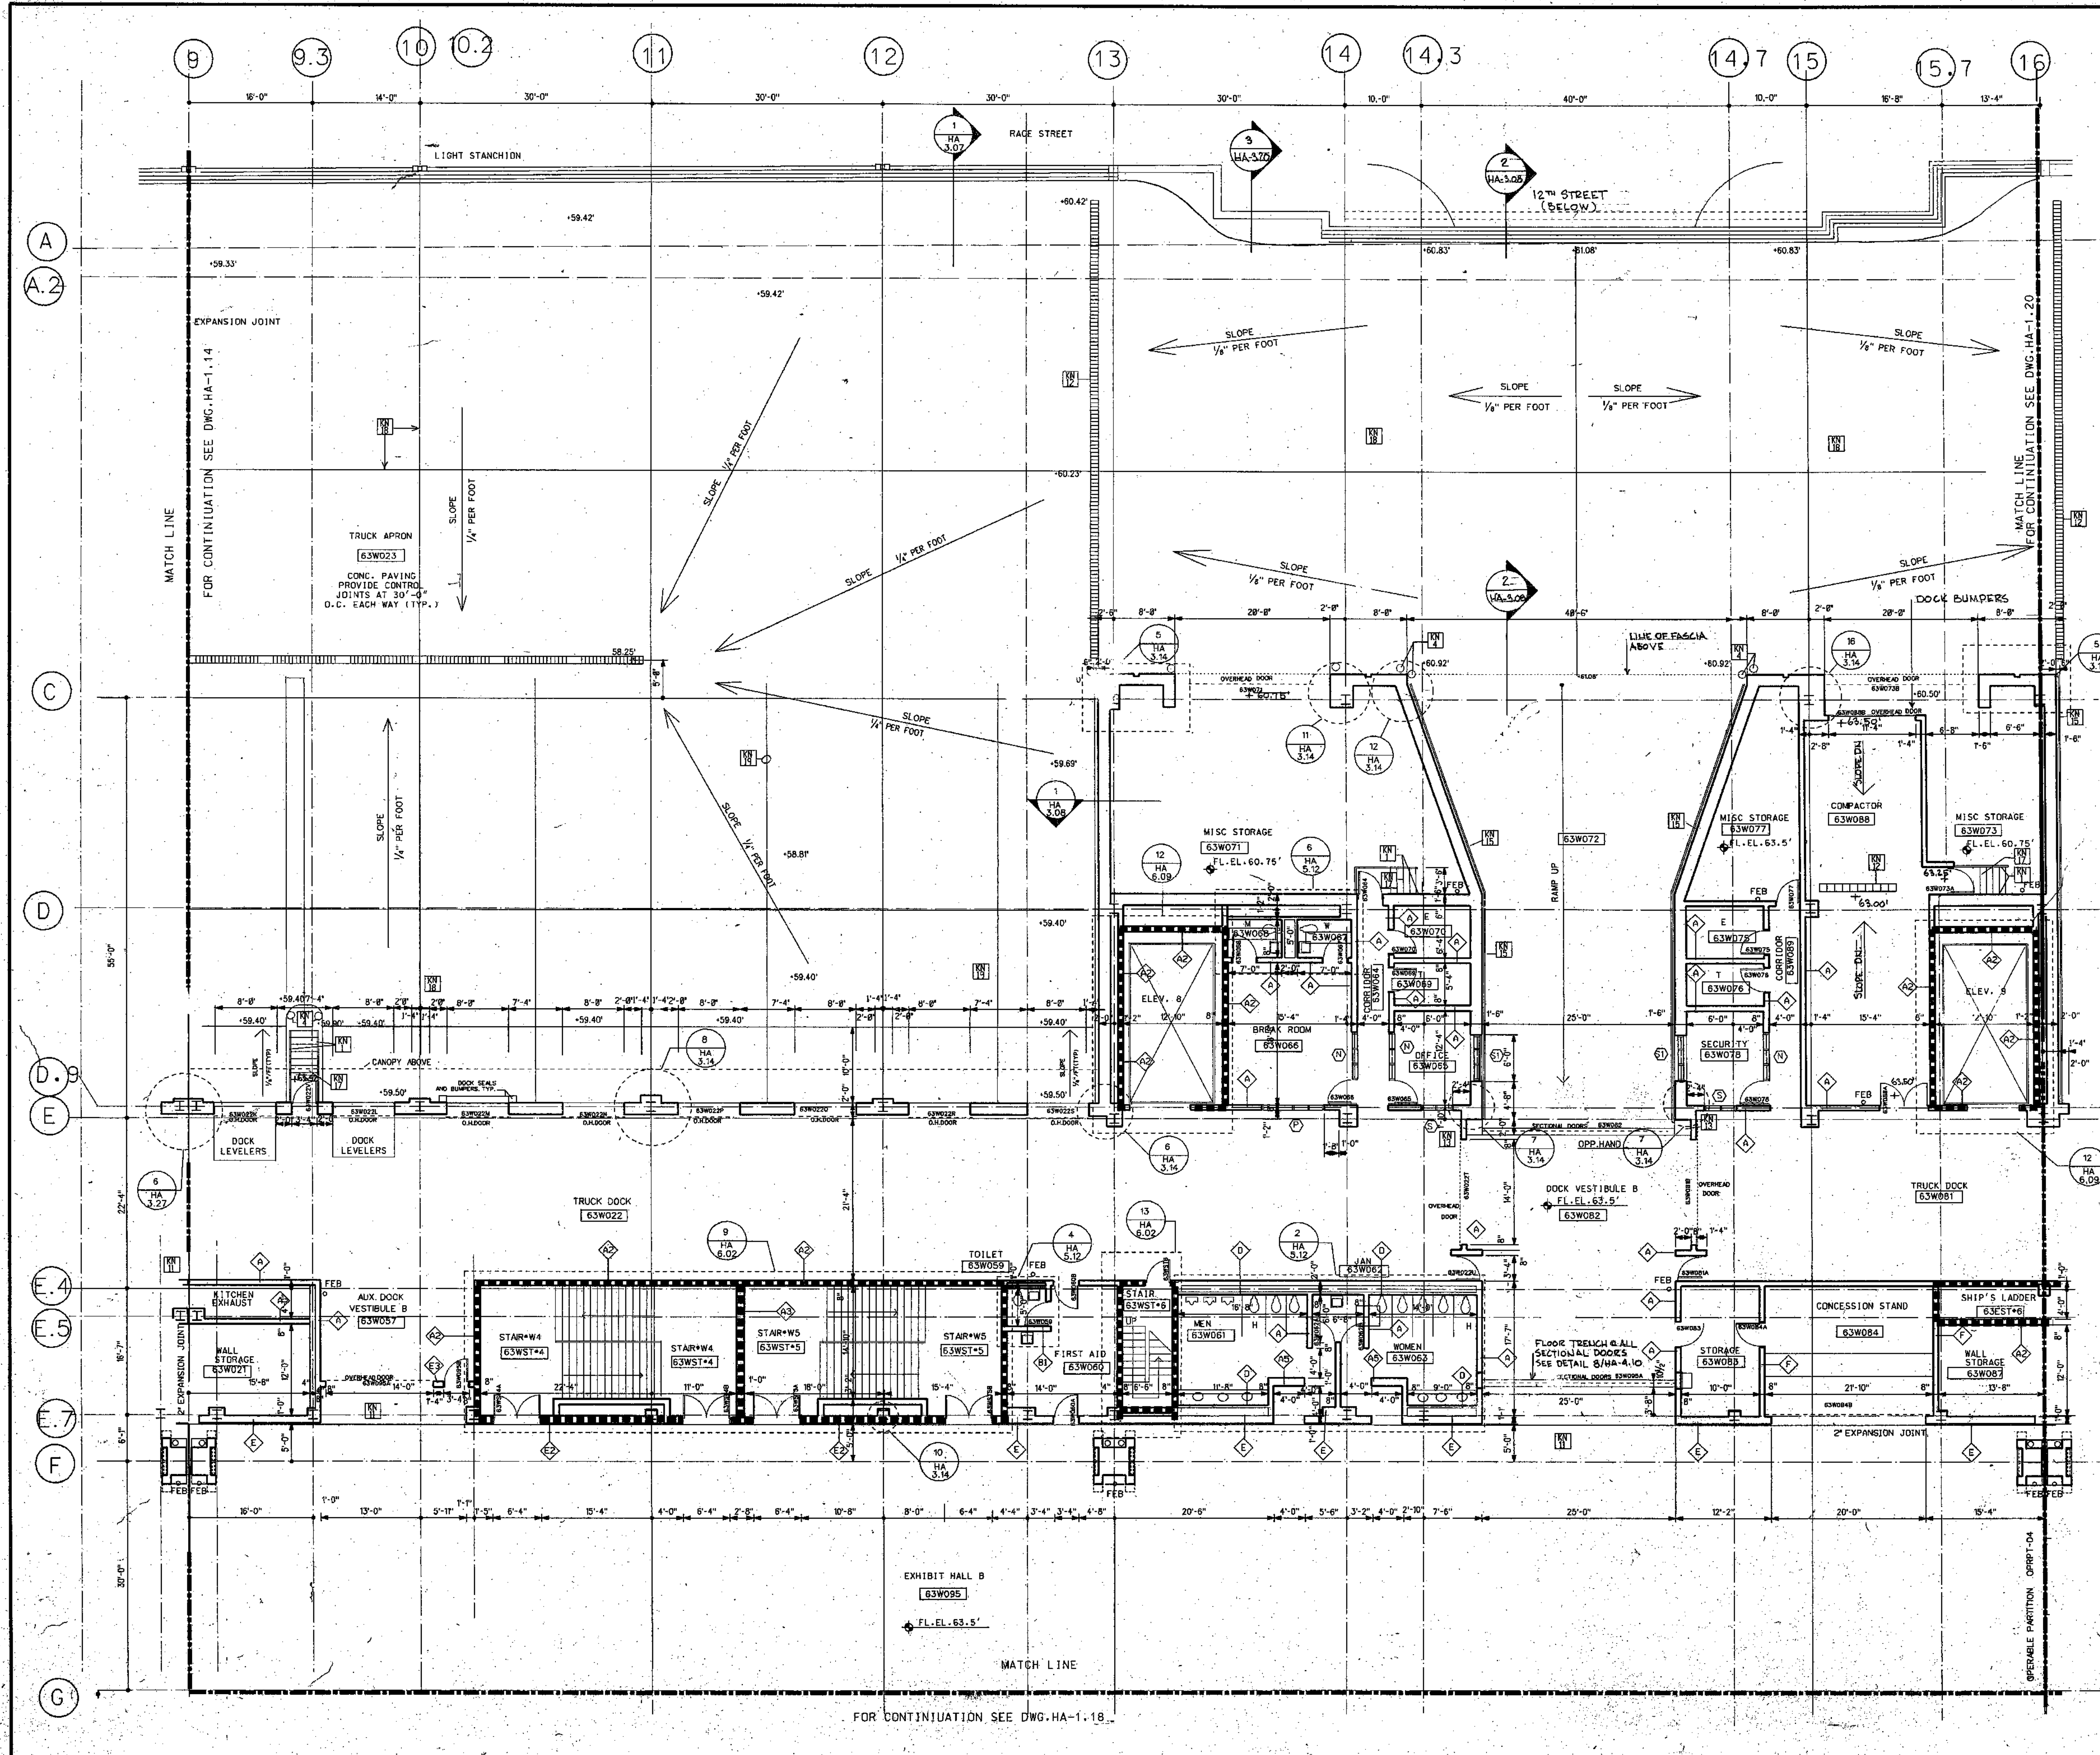

GENERAL NOTES:


1. ALL DIMENSIONS GIVEN ARE NOMINAL AND ARE TAKEN TO THE FACE OF CMU CONSTRUCTION WHERE PARTITIONS ARE CMU OR BACKED UP BY CMU. DIMENSIONS AT METAL FRAME C.W.B. PARTITIONS ARE GIVEN TO FINISH FACE.
2. FOR PARTITION TYPES REFER TO DWG. HA-8.01
3. WALLS INDICATED TO BE RATED CONSTRUCTION SHALL BE CONTINUOUS TO EXTERIOR WALL AND UNDERSIDE OF DECK OR SLAB.
4. FOR ADDITIONAL INFORMATION REGARDING FOOD SERVICE AREAS REFER TO FOOD SERVICE DWG. HK--5. FOR MILLWORK & CASEWORK REFER TO INTERIOR DESIGN DRAWINGS (I.D. DWGS.)
5. FOR FLOORING PATTERNS & MATERIALS REFER TO INTERIOR DESIGN DRAWINGS DWG. HD--1 (NOTE: EXTENT OF STONE FLOORING REQUIRING DEPRESSED CONCRETE SLAB IS INDICATED ON I.D. DRAWINGS ONLY.)
6. FOR EXTENT AND TYPE OF APPLIED FINISHES REFER TO FINISH SCHEDULE
7. REFER TO CIVIL ENGINEERING DRAWINGS FOR EXTENT OF SIDEWALKS, CURBS & MISC. SITE WORK.
8. ALL WOOD WINDOWS & MILLWORK ARE INDICATED ON INTERIOR DESIGN DWGS. (I.D. DWGS.)
9. FOR PLAZA PLAN AND SITE PAVING SEE DWG. HA 8.09

KEY NOTES

[Symbol]	REMOVABLE HANDRAIL
[Symbol]	HANDRAIL
[Symbol]	ORNAMENTAL HANDRAIL
[Symbol]	SOFFIT ABOVE
[Symbol]	STL. BOLLARD
[Symbol]	EDGE OF SLAB
[Symbol]	1" DEPRESSED SLAB FOR PEDIMAT
[Symbol]	6" DEPRESSED SLAB FOR VEST. MAT.
[Symbol]	2" DEPRESSED SLAB FOR TILE FLOORING
[Symbol]	2" DEPRESSED SLAB FOR WALK IN REF./FRZ.
[Symbol]	OPERABLE PARTITION, FOR CEILING TRACK & EXTENT OF C.W.B. PARTITION ABOVE CEILING SEE REFLECTED CEILING PLAN
[Symbol]	2" EXPANSION JOINT (TYPICAL)
[Symbol]	TRENCH DR.
[Symbol]	COUNTER W/ TOWER FOR SECTIONAL DOOR
[Symbol]	6" CONC. CURB
[Symbol]	GUARD RAIL
[Symbol]	CONCRETE WALK
[Symbol]	CAST IN PLACE CONCRETE STEPS WITH PAINTED HANDRAIL
[Symbol]	CONTROL JOINT (TYPICAL)
[Symbol]	PAINTED STRIPES @ EA. TRUCK DOCK

LEGEND

[Symbol]	MATCH LINE
[Symbol]	COLUMN CENTER LINE
[Symbol]	PROPERTY LINE
[Symbol]	1HR FIRE RATED WALL
[Symbol]	2HR FIRE RATED WALL
[Symbol]	3HR FIRE RATED WALL
[Symbol]	PARTITION TYPE
[Symbol]	KEY NOTES
[Symbol]	DOOR NUMBER
[Symbol]	ROOM NUMBER
[Symbol]	PLAN DETAIL
[Symbol]	SECTION DETAIL
[Symbol]	DIMENSION CENTER LINE OF COLUMN TO FACE CMU
[Symbol]	NT. H.M. BORROWED LIGHTS INT. WOOD BORROWED LIGHTS SEE I.D. DWGS.

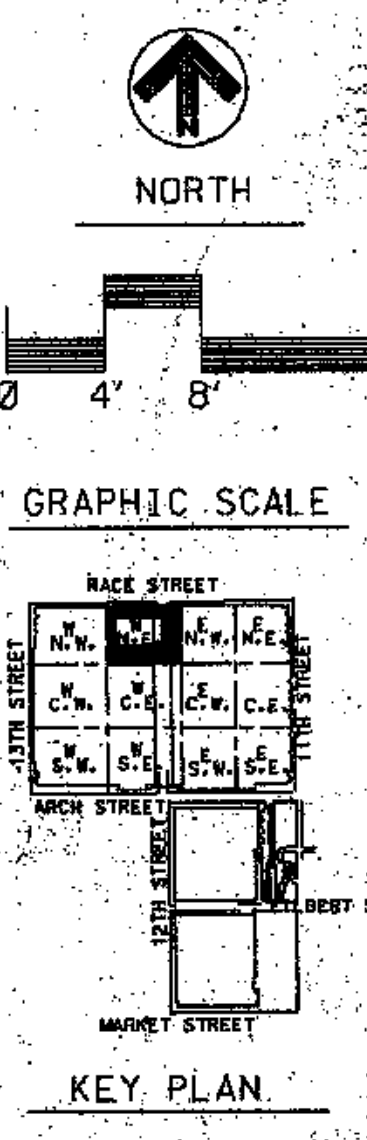

THOMPSON VENTULETT STAINBACK & ASSOCIATES, INC ARCHITECTS

VITETTA GROUP ASSOCIATED ARCHITECT

KELLY MAIELLO ARCHITECTS & PLANNERS, INC.

LIVINGSTON/ROSENWINKEL, P.C. ARCHITECTS & PLANNERS CONSULTING ARCHITECT

NO.	DESCRIPTION	DATE

REVISIONS

All dimensions shall be verified by contractor and architect prior to any discrepancies before proceeding with construction.


DRAWING TITLE
FLOOR PLAN
HALL LEVEL
EL. 63-0'

BLOCK "W" IN E

PROJECT NO. 8803.00
VG
5134
ISSUE DATE 8-27-90

HA 1.17

PHILADELPHIA, PENNSYLVANIA
PENNSYLVANIA CONVENTION CENTER

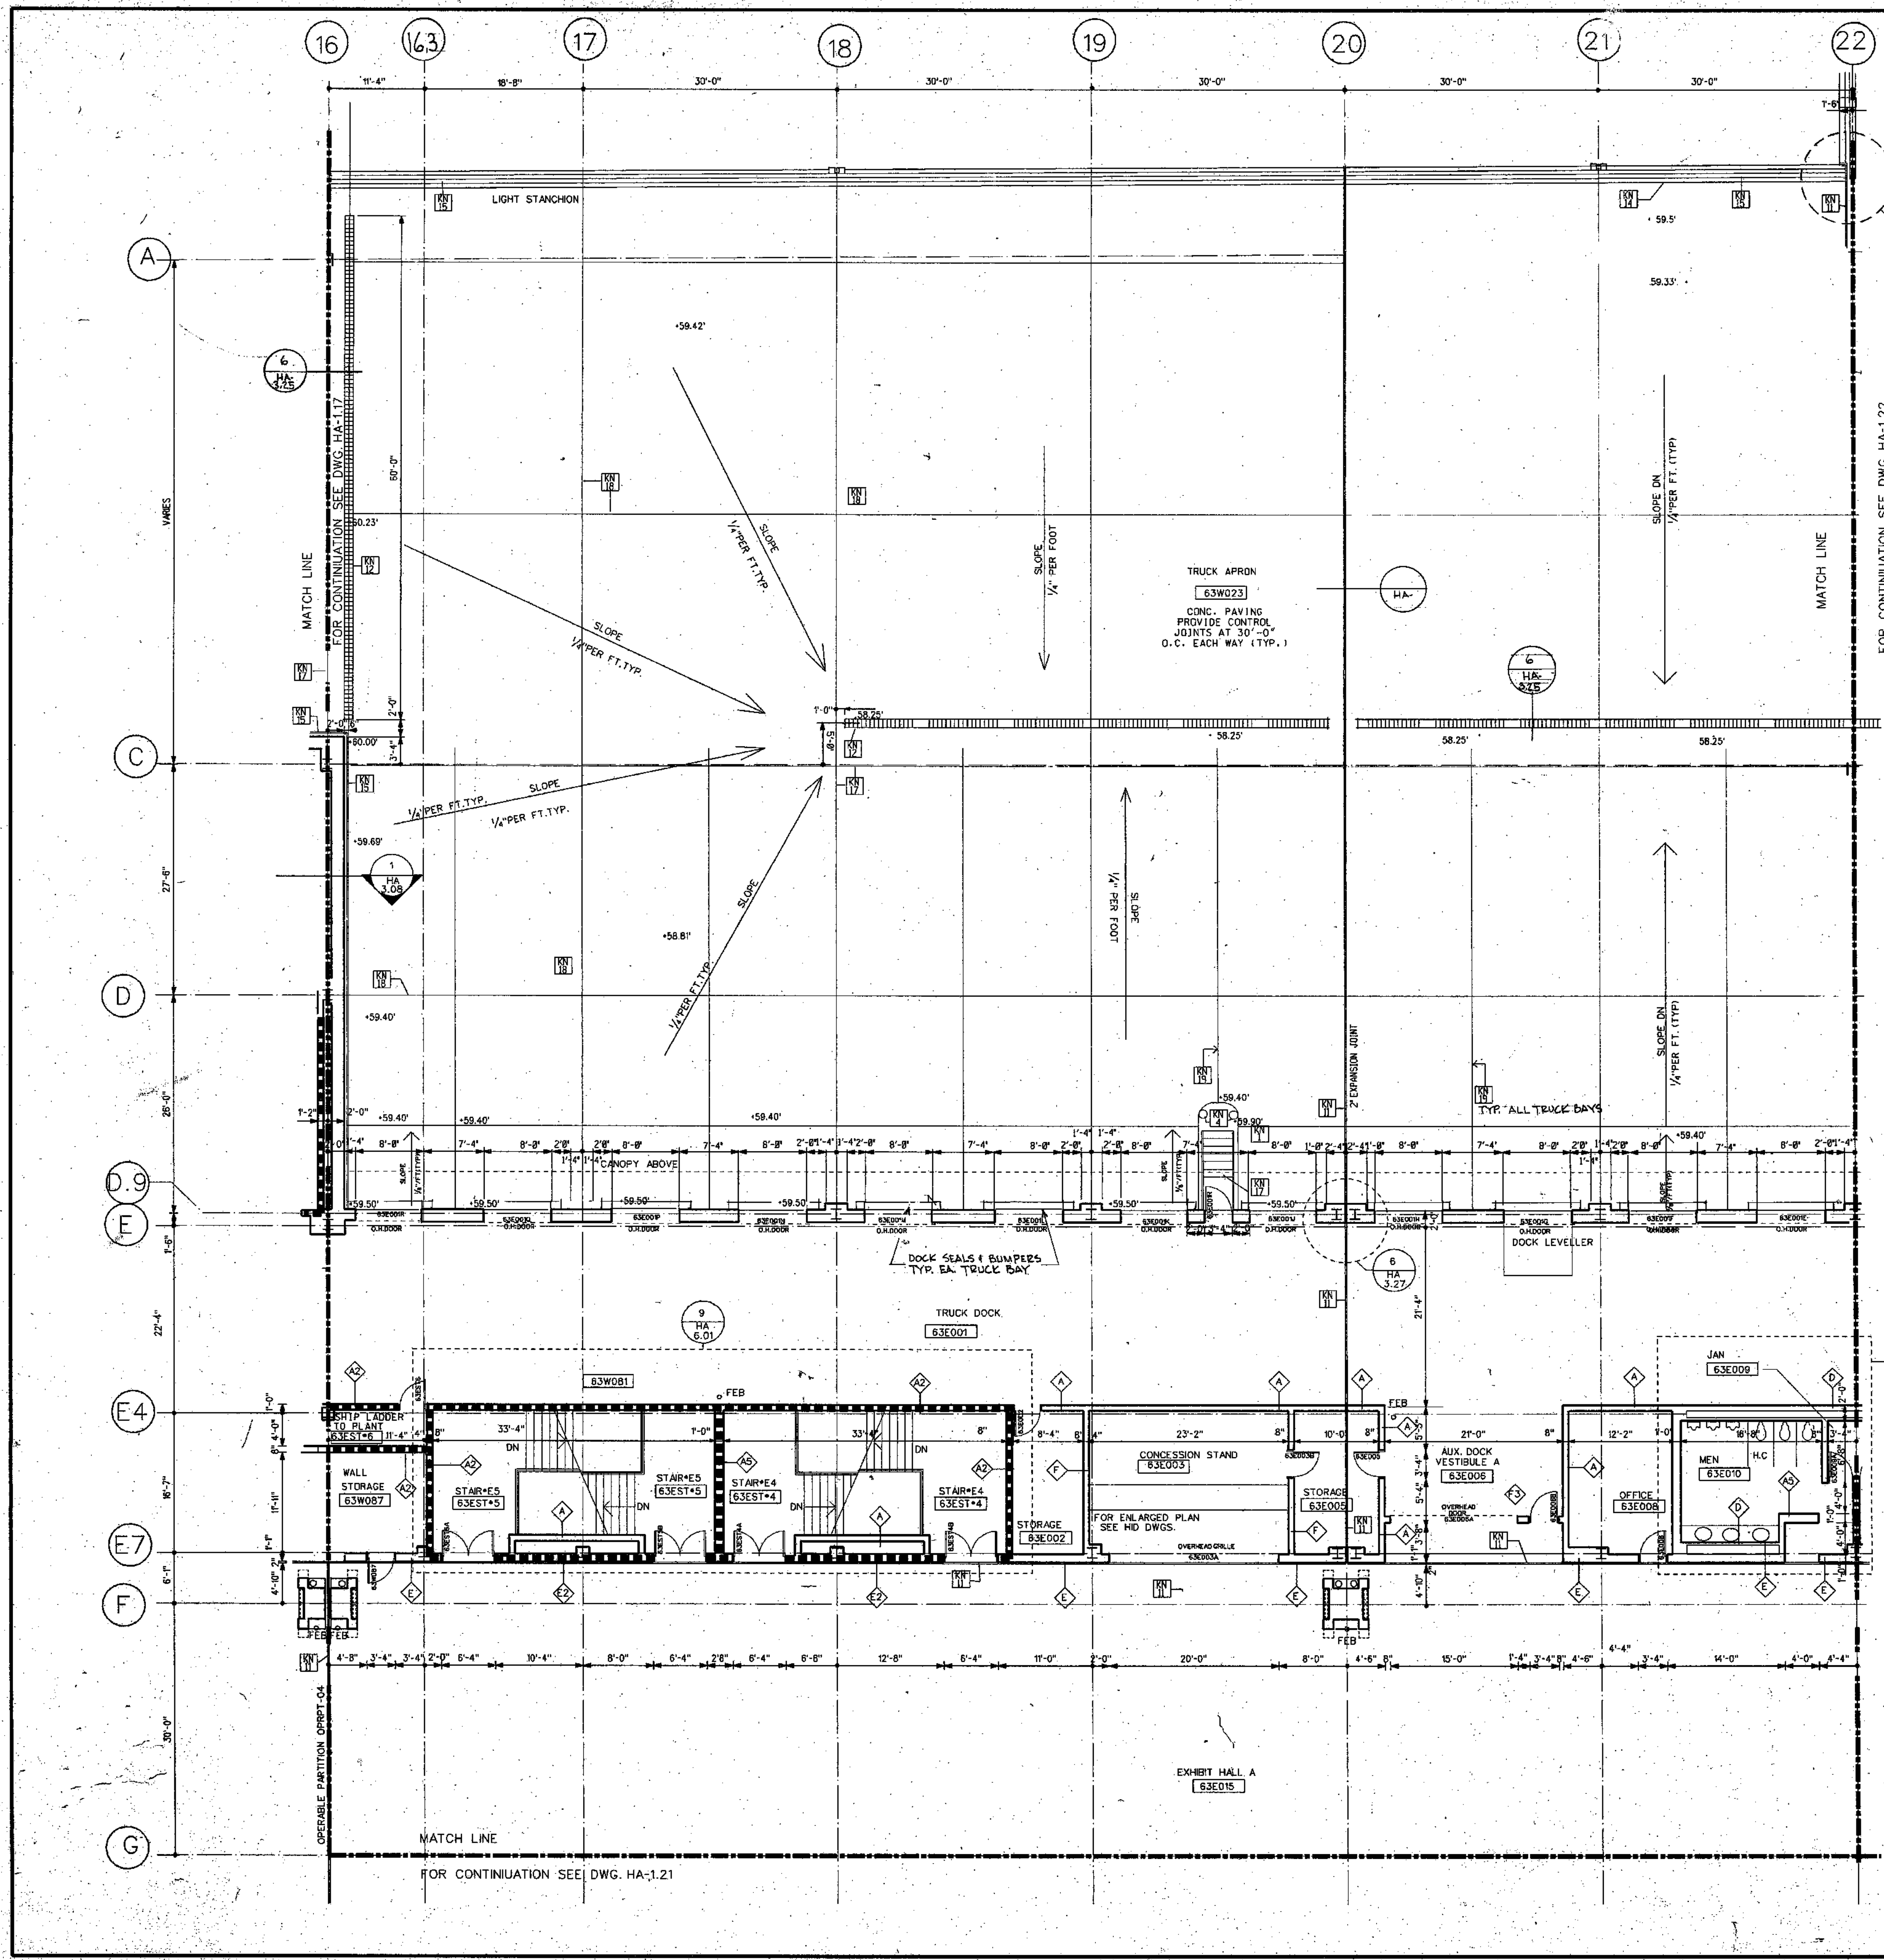


GENERAL NOTES:

1. ALL DIMENSIONS GIVEN ARE NOMINAL AND ARE TAKEN TO THE FACE OF CMU CONSTRUCTION WHERE PARTITIONS ARE CMU OR BACKED UP BY CMU. DIMENSIONS AT METAL FRAME C.W.B. PARTITIONS ARE GIVEN TO FRESH FACE.
2. FOR PARTITION TYPES REFER TO DWG. HA-5.01
3. WALLS INDICATED TO BE RATED CONSTRUCTION SHALL BE CONTINUOUS TO EXTERIOR WALL AND UNDERSIDE OF DECK OR SLAB.
4. FOR ADDITIONAL INFORMATION REGARDING FOOD SERVICE AREAS REFER TO FOOD SERVICE DWG. HK-5.01
5. FOR MILLWORK & CASEWORK REFER TO INTERIOR DESIGN DRAWINGS (H.D. DWGS.)
6. FOR FLOORING PATTERNS & MATERIALS REFER TO INTERIOR DESIGN DRAWINGS (H.D. DWGS.)
7. FOR EXTENT OF STONE FLOORING REQUIRING DEPRESSED CONCRETE SLAB IS INDICATED ON HD DRAWINGS (ONLY).
8. REFER TO CIVIL ENGINEERING DRAWINGS FOR EXISTENT OF SIDEWALKS, CURBS & MISC. SITE WORK.
9. ALL WOOD WINDOWS & MILLWORK ARE INDICATED ON INTERIOR DESIGN DWGS. (H.D. DWGS.)
10. FOR PLAZA PLAN AND SITE PAVING SEE DWG. HA. B.09

- KEY NOTES**
- [Symbol] REMOVABLE HANDRAL
 - [Symbol] HANDRAL
 - [Symbol] ORNAMENTAL HANDRAL
 - [Symbol] SOFFIT ABOVE
 - [Symbol] STL. BOLLARD
 - [Symbol] EDGE OF SLAB
 - [Symbol] 1" DEPRESSED SLAB FOR PEDIMAT.
 - [Symbol] 6" DEPRESSED SLAB FOR VEST.MAT.
 - [Symbol] 2" DEPRESSED SLAB FOR TILE FLOORING
 - [Symbol] 2" DEPRESSED SLAB FOR WALK IN REF/FREZ.
 - [Symbol] OPERABLE PARTITION FOR CEILING TRACK & EXTENT OF C.W.B. PARTITION ABOVE CEILING SEE REFLECTED CEILING PLAN
 - [Symbol] 2" EXPANSION JOINT (TYPICAL)
 - [Symbol] TRENCH DRAIN
 - [Symbol] COUNTER WT. TOWER FOR SECTIONAL DOOR
 - [Symbol] 6" CONC. CURB
 - [Symbol] GUARD RAIL
 - [Symbol] CONCRETE WALK
 - [Symbol] CAST IN PLACE CONCRETE STEPS WITH PAINTED HANDRAL
 - [Symbol] CONTROL JOINT (TYPICAL)
 - [Symbol] PAINTED STRIPES

- LEGEND**
- [Symbol] MATCH LINE
 - [Symbol] COLUMN CENTER LINE
 - [Symbol] PROPERTY LINE
 - [Symbol] 1HR FIRE RATED WALL
 - [Symbol] 2HR FIRE RATED WALL
 - [Symbol] 3HR FIRE RATED WALL
 - [Symbol] PARTITION TYPE
 - [Symbol] KEY NOTES
 - [Symbol] DOOR NUMBER
 - [Symbol] ROOM NUMBER
 - [Symbol] PLAN DETAIL
 - [Symbol] SECTION DETAIL
 - [Symbol] DIMENSION CENTER LINE OF COLUMN TO FACE CMU
 - [Symbol] INT. H.M. BORROWED LIGHTS INT. WOOD BORROWED LIGHTS SEE HD DWGS.

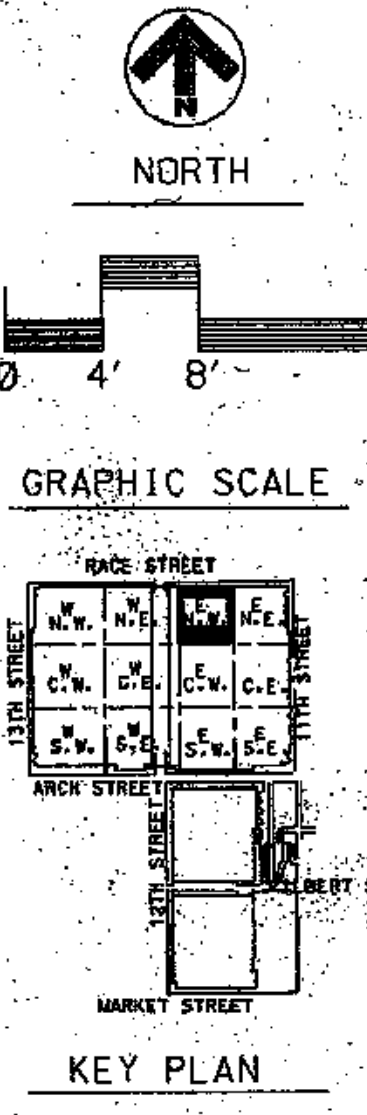

THOMPSON VENTULETT STAINBACK & ASSOCIATES, INC ARCHITECTS

VITETTA GROUP ASSOCIATED ARCHITECT

KELLY/MAIELLO ARCHITECTS & PLANNERS, INC.

LIVINGSTON/ROSENWINKEL, P.C. ARCHITECTS & PLANNERS CONSULTING ARCHITECT

REVISIONS

All dimensions shall be verified by contractor and architect notified of any discrepancies before proceeding with construction.



James J. White
 DRAWING TITLE
**FLOOR PLAN
 HALL LEVEL
 EL. 63'-0"**

BLOCK "E" N.W.
 PROJECT NO. DRAWING NO.
 TV568
 8883.00
 VG.
 5134
 ISSUE DATE
 8-27-90
**HA
 1:20**