

LIGHTING COORDINATION NOTES

- REFER TO LIGHTING FIXTURE SCHEDULES ON DRAWINGS ELS01 THROUGH ELS04 FOR ALL SPECIALTY AND BACK-OF-HOUSE LIGHT FIXTURE DEFINITIONS.
- COORDINATE WITH REFLECTED CEILING PLAN (RCP) DRAWING SERIES A6.10 AND FOLLOWING FOR ALL CEILING HEIGHTS AND EXACT LOCATIONS FOR CEILING MOUNTED LIGHT FIXTURES.
- COORDINATE WITH ARCHITECTURAL BUILDING ELEVATION DRAWING SERIES A-300 FOR EXACT MOUNTING HEIGHTS OF ALL OUTSIDE BUILDING MOUNTED LIGHT FIXTURES.
- FOR MOUNTING ORIENTATION OF ALL COVE MOUNTED LIGHTING IN TOILET ROOMS (FS-1 & FS-2 FIXTURES) REFER TO ARCHITECTURAL DETAILS G12 & A14 ON DRAWING A-670. (TYP)
- FOR MOUNTING ORIENTATION OF ALL COVE MOUNTED LIGHTING IN CORRIDORS, PRE-FUNCTION AND OTHER PUBLIC CIRCULATION AREAS, (FW-2 & FW-4 FIXTURES) REFER TO DETAIL E12 ON DRAWING A-670. (TYP)
- FOR MOUNTING ORIENTATION OF ALL DOWNLIGHTS AT MEETING ROOM ENTRANCES AND WINDOWS, REFER TO ARCHITECTURAL DETAILS E1, E6, L1 & L6 ON DRAWING A-670, AND DETAILS G1 & G6 ON DRAWING A-671. (TYP)
- FOR MOUNTING ORIENTATION OF ALL QUARTZ WALLWASHER "LOW-1" FIXTURES IN PUBLIC CORRIDORS, REFER TO ARCHITECTURAL DETAIL AS ON DRAWING A-671. (TYP)
- WHERE APPLICABLE TO LIGHTING INSTALLATION, UTILIZE THE STANDARDS AND GUIDELINES OUTLINED ON "MISS ELECTRICAL DETAILS" DRAWINGS EP401, EP402 AND EP403.
- ALL "C-EM" FIXTURE MOUNTED IN STAIRWELLS SHALL BE WALL MOUNTED AT 7'-0" ABOVE LANDING. COORDINATE WITH ALL OTHER TRADES FOR INSTALLATION OF OTHER EQUIPMENT IN STAIRWELLS, E.G. FIRE PROTECTION FCVA LOCATIONS, ETC.
- MANY OF THE SPECIALTY LIGHTING FIXTURES HAVE SPECIFIC CONSTRUCTION AND MOUNTING REQUIREMENTS. TO REVIEW THIS INFORMATION, REFER TO FIXTURE MANUFACTURER'S CUTS PACKAGE AT END OF LIGHTING SPECIFICATIONS

CONTRACT 2 SCOPE OF WORK
ALL THE WORK SHOWN ON THIS DRAWING IS PART OF THE WORK OF CONTRACT 2



PICTURE 1/232

NOTE: COORDINATE LIGHTING INSTALLATION WITH ELECTRICAL GEAR AND ASSOCIATED CONDUITS SO LIGHTING IS NOT BLOCKED.

REFER TO PICTURE 1/232

NOTE: THE MECH UNIT FOOTPRINT OUTLINE IS SHOWN ONLY. DUCTWORK AND PIPING ARE NOT SHOWN TO MAINTAIN DRAWING CLARITY. COORDINATE LIGHT FIXTURE LOCATIONS WITH MECHANICAL AND ELECTRICAL EQUIPMENT, PIPING, CONDUIT, DUCTWORK, ETC. SO LIGHTING IS NOT BLOCKED.

NOTE: ALL LIGHTING CABLE FOR FIXTURES MOUNTED TO TRUSS SHALL BE CABLE ROUTED INSIDE TRUSS.

PROJECT NO. 00002
PROJECT: Contract 2 - General Construction
DATE: 10/20/2009
REQUIRED DATE: 11/10/2009

SUBJECT: Mechanical Rooms @ Level 3 and 2
SPEC SECTION:

REQUEST:
Drawing A-212 indicates the air niche elevation is detailed on A11M63, ASB11 required 1463 and alternate niche elevations for both Levels 1 and 2. Please clarify what niche elevations are applicable for interior drawings and confirm if lighting is required in both Level 1 and 2 niche corner.

REPLY:
The level 3 air well remains on the project at level 1 and level 2, the air niche level is provided only at level 1. Elevation originally tagged as A1-352 will be relocated to a new sheet in a future A/E. At level 2, provide air well with niche as indicated on drawing A-212. Refer to attached sketches SKA-01-11-24-09 through SKA-07-11-24-09. At level 1, provide air well as shown on attached sketches SKA-01-11-24-09 through SKA-07-11-24-09. At level 2, provide lighting for air well area as shown in attached sketches SKA-01-11-24-09 and SKA-09-11-24-09. At level 1, provide lighting for air well area as shown in attached sketches SKA-01-11-24-09, SKA-03-11-24-09, and SKA-09-11-24-09. -RCH 12.2.09

VITETTA
ARCHITECTURE ENGINEERING PLANNING INTERIOR DESIGN
PHILADELPHIA NAVAL BUSINESS CENTER
4747 S. BRAD ST. PHILADELPHIA PA 19112
T 215.218.4747 F 215.218.4740

K Kelly/Majello Inc.
Architects & Planners
1420 WALNUT STREET, 15TH FLOOR
PHILADELPHIA PA 19102-4015
215-546-9800 FAX 215-546-1420

thvs THOMPSON, VENTURETTI, STANBACK & ASSOCIATES, INC.
2700 PROMENADE TWO
1230 PEACHTREE STREET N.E.
ATLANTA, GEORGIA 30309-3591
404-888-6500 FAX 404-888-6700


PROJECT # 9303.0400
ALL DIMENSIONS MUST BE VERIFIED BY CONTRACTOR AND THE ARCHITECT NOTIFIED OF ANY DISCREPANCIES BEFORE PROCEEDING WITH THE CONSTRUCTION. NOT TO SCALE
DRAWING 00002.VITETTA

RECEIVED
April 2, 2009
The Keating Joint Venture
Job #711.002

KJV - PCI #047

EXPANSION AND RENOVATION TO THE PENNSYLVANIA CONVENTION CENTER
1101 ARCH STREET • PHILADELPHIA, PENNSYLVANIA 19107

PENNSYLVANIA CONVENTION CENTER AUTHORITY
ONE PENNSYLVANIA CONVENTION CENTER PLACE
PHILADELPHIA, PENNSYLVANIA 19107

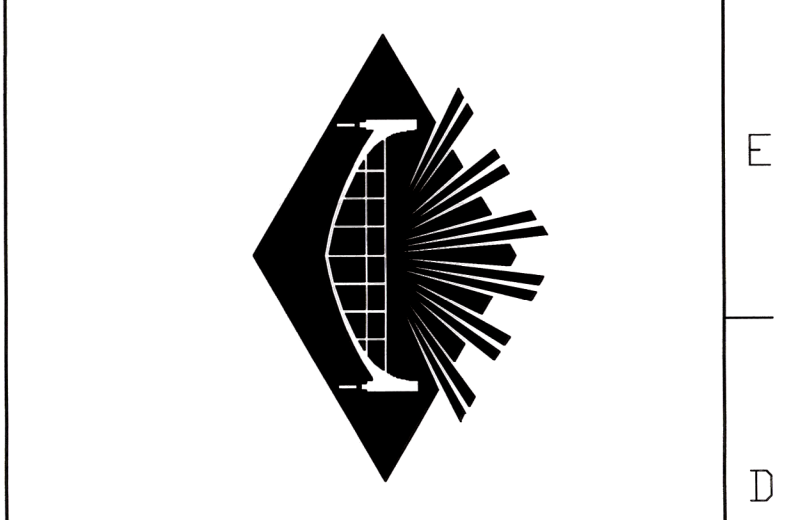

CONTRACT 2
WORK SHOWN IS WORK OF CONTRACT #2 AND IS DESCRIBED IN DIVISION 01 SECTION 1000 "SUMMARY OF THE WORK". WORK IDENTIFIED AS "NOT IN CONTRACT" (NIC) IS WORK OF CONTRACT #1 AND IS SHOWN FOR THE PURPOSE OF REFERENCE & COORDINATION

NO.	REVISIONS	DATE
11	CONFORMED SET - ISSUED FOR CONSTRUCTION	10/20/09
12	ASI #12	02/19/09
18	ASI-18	3/19/08
	CE-RFI-524	

DRAWING TITLE: **LEVEL-3 LIGHTING PLAN SOUTHWEST**

PROJECT NO. VIT 9303.04
DRAWING NO. EL232

KEYPLAN LEVEL-3
LEVEL-3 NORTH ELEV. 84'-10"
LEVEL-3 SOUTH ELEV. 76'-10"

LEVEL 3 FLOOR PLAN - SOUTHWEST
SCALE: 1/8" = 1'-0"